

| | | | |
|---------------|---|--------------------------|---|
| APPROVED | | | |
| TOWN ENGINEER | | TRIPLE THREE ENGINEERING | |
| BENCH MARKS | | | |
| BM | Y | X | Z |
| | | | |

- GENERAL NOTES**
1. THE CONTRACTOR IS TO CONFIRM ALL DIMENSIONS ON SITE AND TO REPORT ANY DISCREPANCIES TO THE ENGINEER IMMEDIATELY.
 2. ALL WORK IS TO BE EXECUTED IN ACCORDANCE WITH THE PROVISIONS OF SANS 1200.
 3. NOTE THAT NO OTHER BURIED SERVICES ARE INDICATED ON THIS DRG.
 4. DIMENSIONS ARE NOT TO BE SCALED FROM THIS DRAWING.
 5. THIS DRAWING IS NOT TO BE USED FOR CONSTRUCTION UNLESS SPECIFICALLY DIRECTED OR INDICATED.
 6. THE CONTRACTOR IS REQUIRED TO MINIMISE DUST AND NOISE NUISANCE TO ALL SURROUNDING PROPERTIES.
 7. A MINIMUM NOTICE PERIOD OF 24 HOURS IS REQUIRED FOR ANY INSPECTION.
 8. CONTRACTOR IS TO PROVIDE A DETAILED SCHEDULE OF INFORMATION REQUIRED INDICATING ALL SUCH DATES.

LEGEND

- UNDERGROUND MV CABLE FOR RING NETWORK
- X ESKOM SUBSTATION
- 1600 KVA MINI / 800 KVA MINI
- RMU


REVISIONS

| B | JRD | DATE | REVISION |
|---|-----|------------|-----------------------|
| B | JRD | 2018-05-17 | ISSUED FOR DISCUSSION |
| A | JRD | 2018-03-03 | ISSUED FOR DISCUSSION |

CLIENT INFORMATION

| NO. | DRAWN | DATE | REVISION |
|-----|-------|------|----------|
| | | | |

CONSULTING ENGINEERS
 Western Cape Office - 18 on Main Street, Paarl, 7646 / P O Box 200, Paarl, 7620
 Gauteng Office - 16 Krusiebessie Road, Unit 33 Eagles View, Roodekrans, /
 P O Box 6403, Weltevreden Park, 1715
 Tel 021 863 1244/6. Fax 021 863 1246 or 086 263 3934 / info@triple3.co.za / www.triple3.co.za

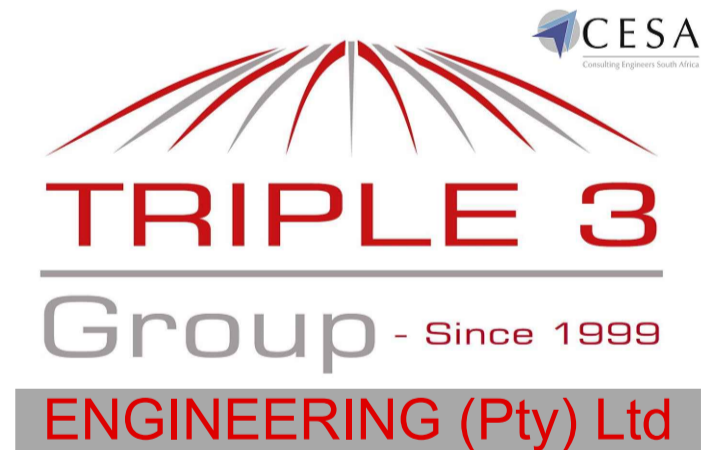

| | | | |
|--|------------------|--------------------|----|
| PROJECT | | | |
| ERF 15712 WELLINGTON | | | |
| DESCRIPTION | | | |
| ELECTRICAL LAYOUT | | | |
| DESIGNED PR TECH (ENG) | GLR 200070105 | SCALE 1:2500 | A1 |
| DRAWN PR TECH (ENG) | RA | DATE 2018-03-13 | |
| APPROVED PR TECH (ENG) | GLR 200070105 | CONTRACT NO 323 | |
| DRAWING NO. 323-07-01 | SHEET 1 OF 1 | | |
| PROJECT STATUS | | | |
| <input checked="" type="radio"/> Concept Drawing <input type="radio"/> Approval Drawing <input type="radio"/> Tender Drawing <input type="radio"/> Construction Drawing <input type="radio"/> As-Built Drawing | | | |
| REVISION | X | B | |